


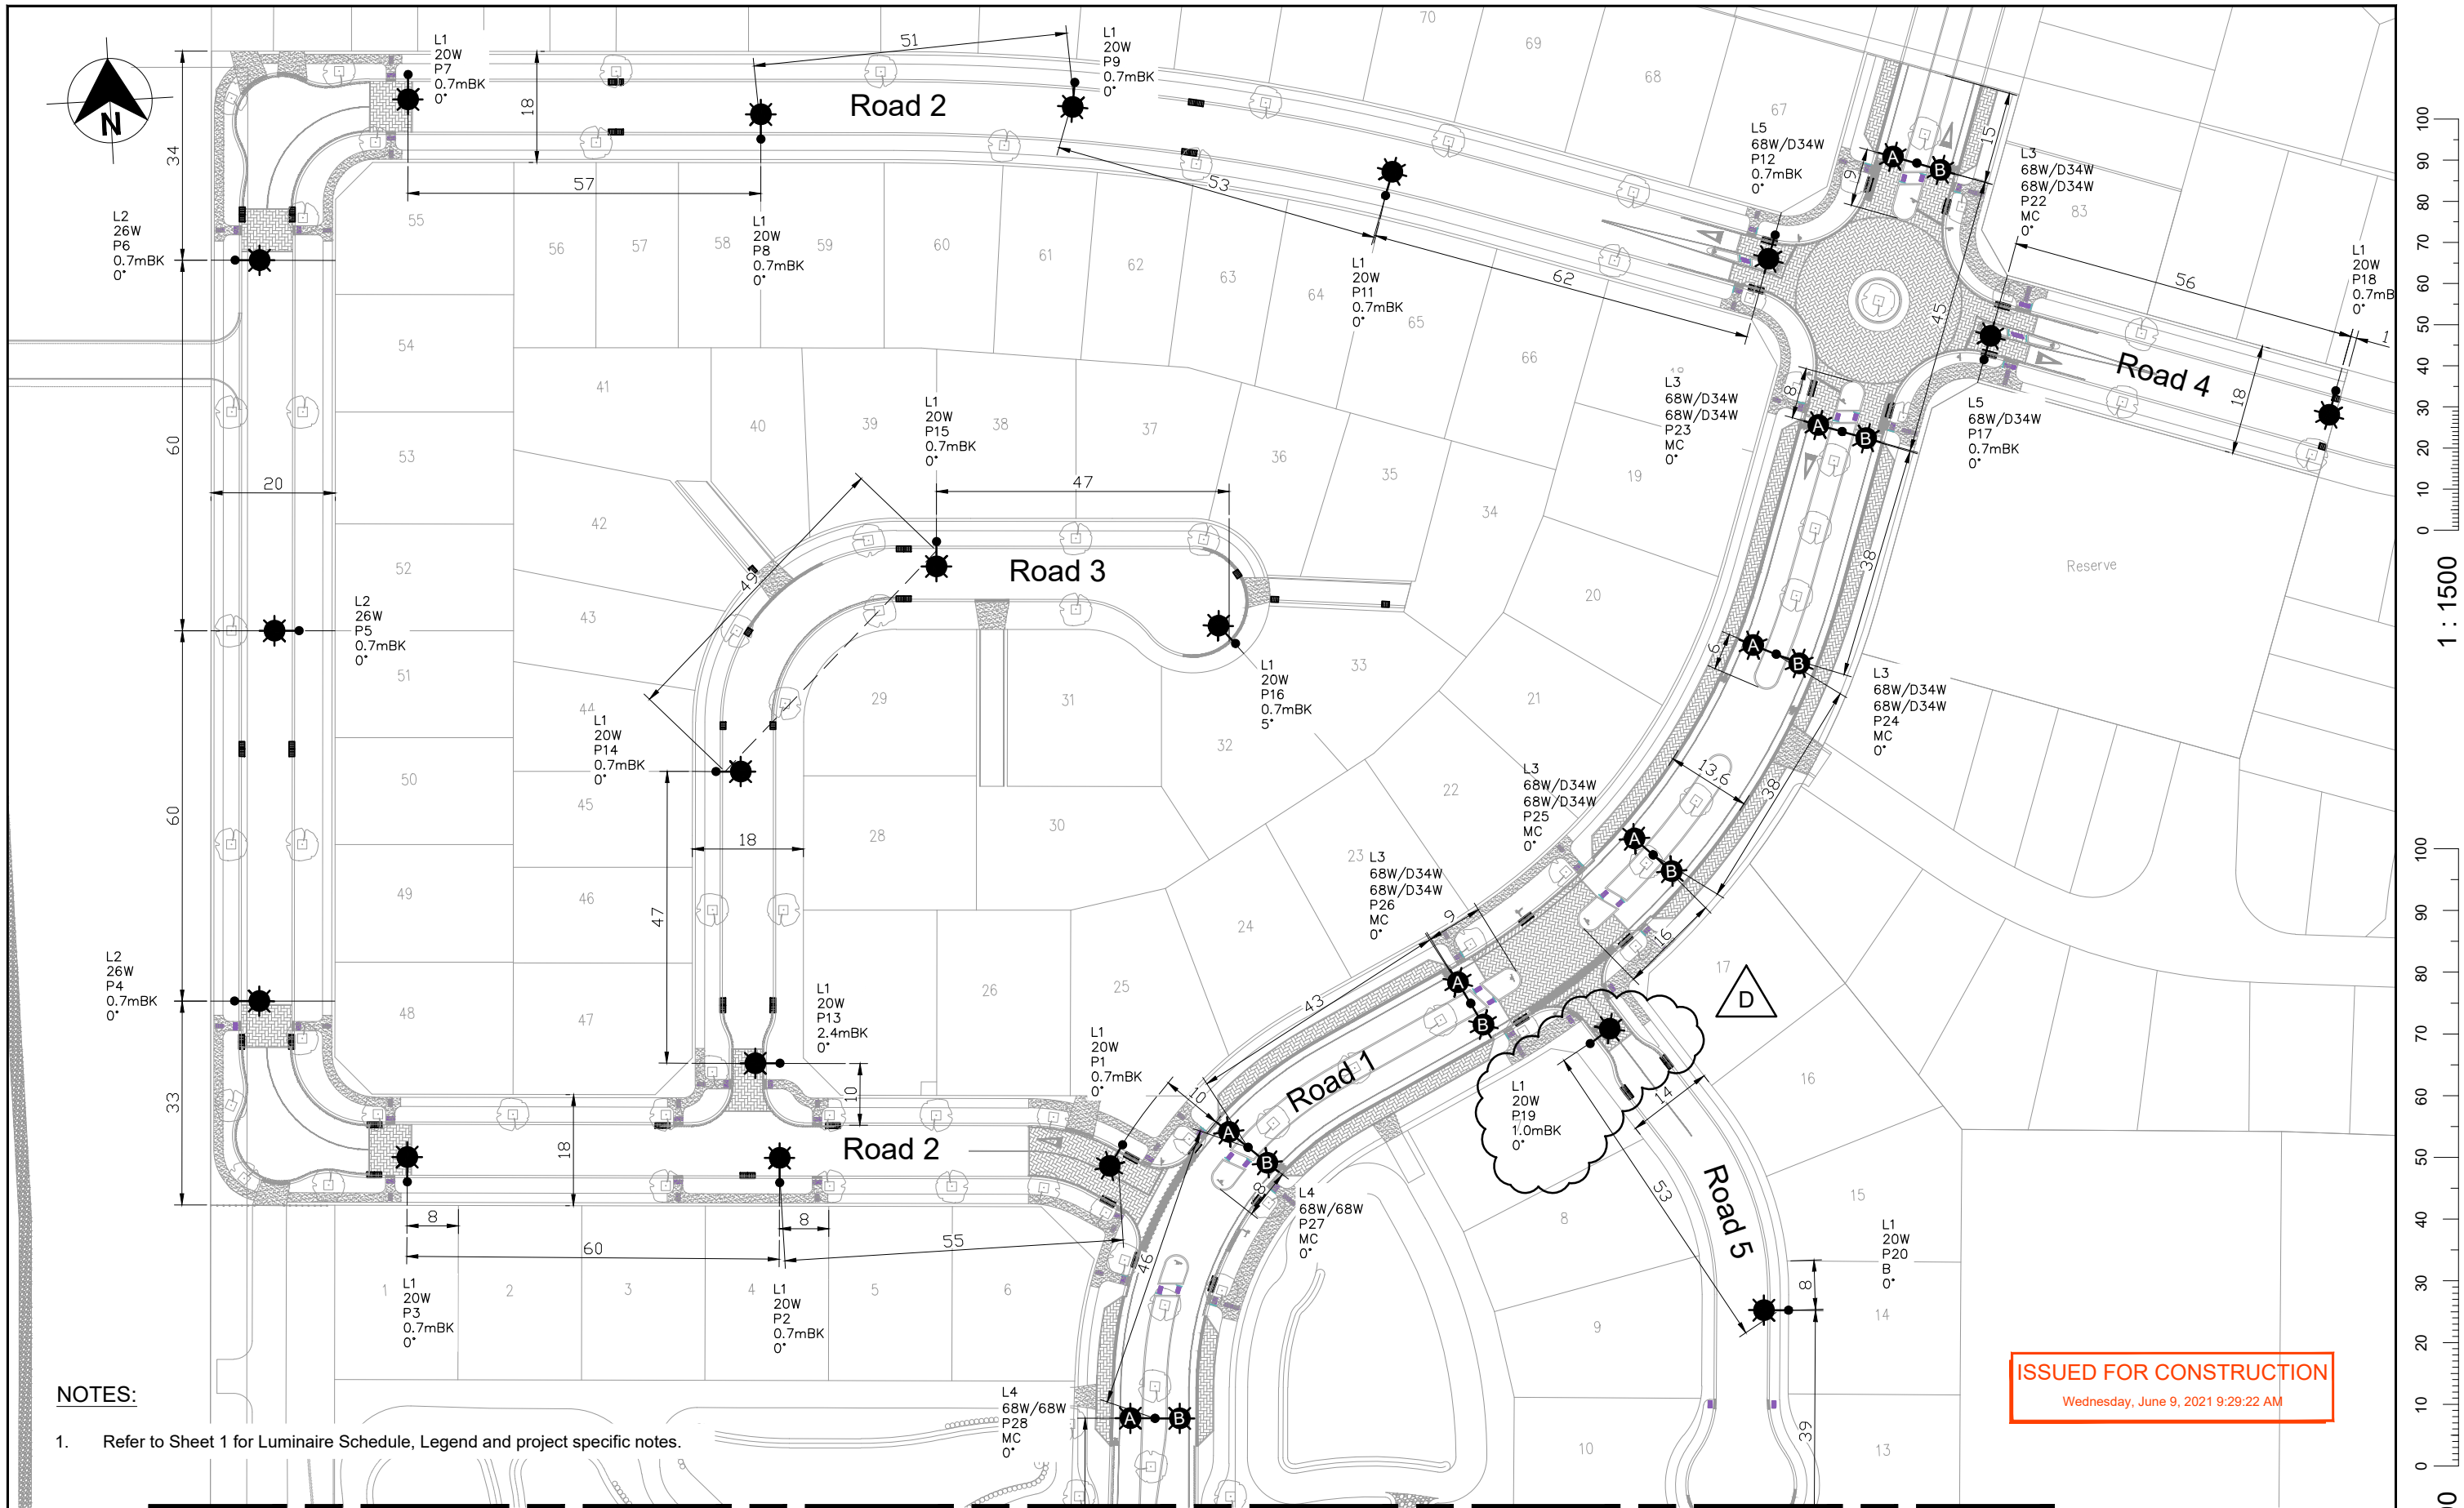

- NOTES:
- 1. Refer to Sheet 1 for Luminaire Schedule, Legend and project specific notes.

ISSUED FOR CONSTRUCTION
Wednesday, June 9, 2021 9:29:22 AM

SEE SHEET 3 FOR CONTINUATION

 WINDSOR URBAN LTD.
ALL RIGHTS RESERVED.
UNAUTHORISED USE PROHIBITED


Rev	Description	Date	Des	Dn	Chk	Apd	Or Apc	Contractor	Designed	R. St-Denis / Conn	Sept 20	Scale
A	Issued to client for comments	04/09/20	RSD	RSD	-	-	-	-	Drawn	R. St-Denis / Conn	Sept 20	1:1000
B	Issued to CCC for Final Approval	21/10/20	RSD	RSD	-	-	-	-	Checked	A. Kudinov / Conn	Oct 20	
C	Issued to CCC for Final Approval	17/11/20	RSD	RSD	-	-	-	-	Approved	G. English / CCC	08/06/21	
D	Column P19 Relocated 1.0m Behind the Kerb	09/06/21	RSD	RSD	-	-	-	-				Revision
												D

STREETLIGHTING LAYOUT

Oakridges Sub-Division
Stage 1
Christchurch



Size	Drawing Number	Sheet
A3	400053	2 / 4

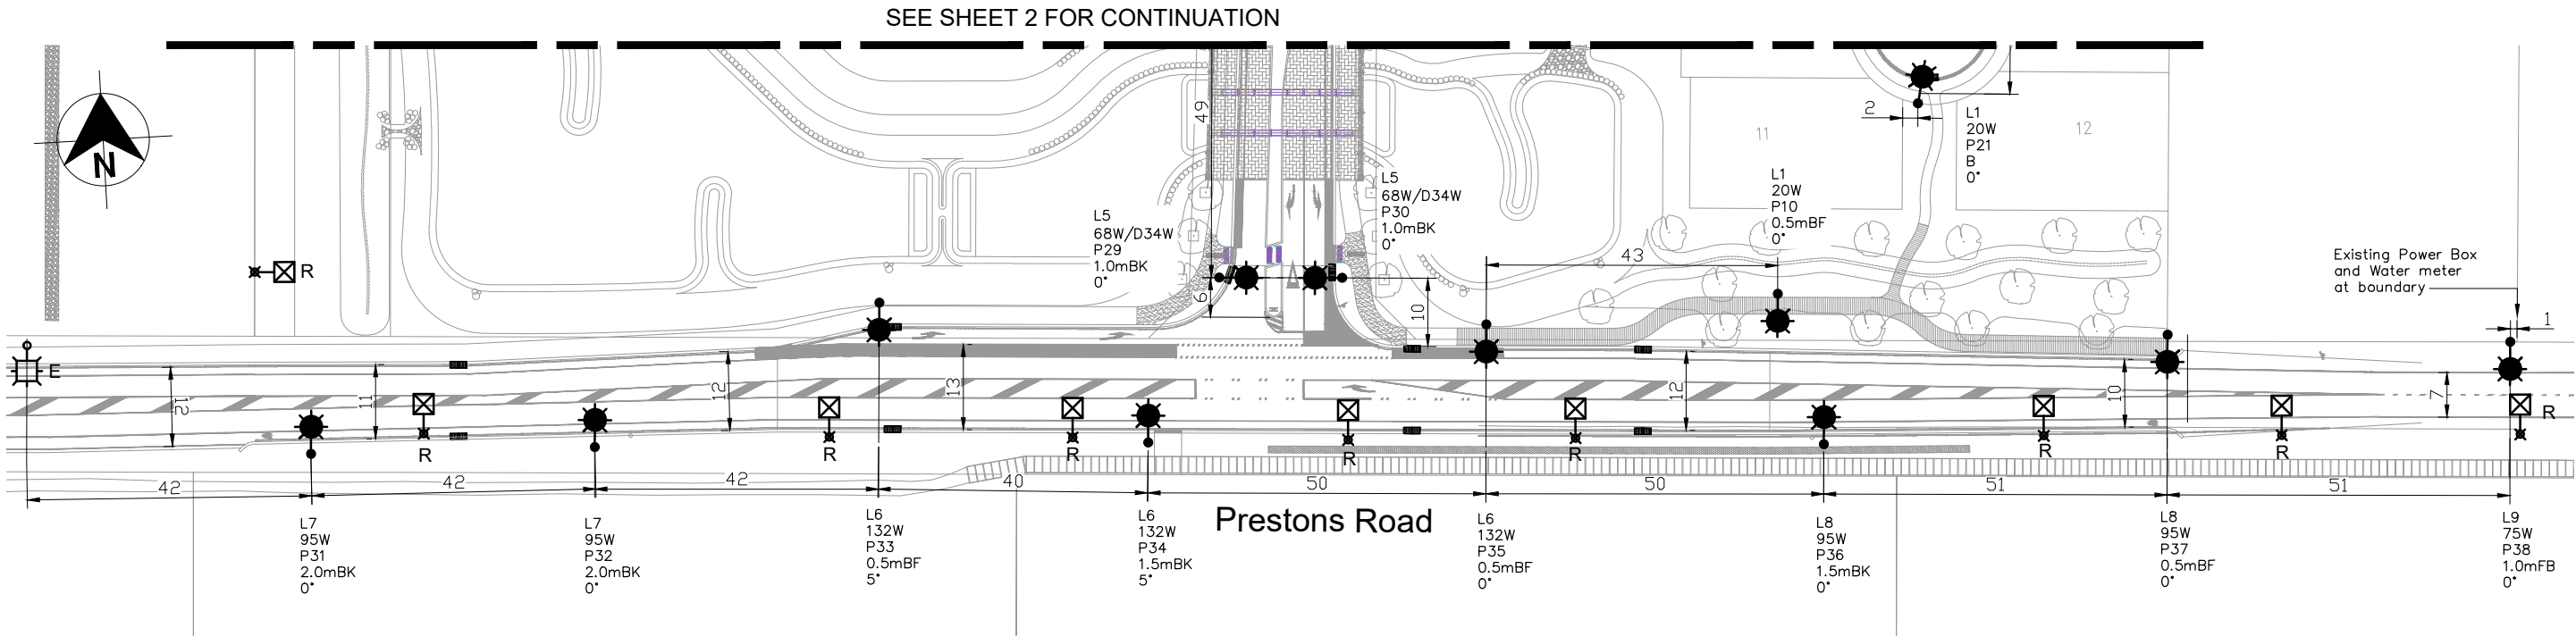

ISSUED FOR CONSTRUCTION

Wednesday, June 9, 2021 9:29:10 AM

NOTES:

1. Refer to Sheet 1 for Luminaire Schedule, Legend and project specific notes.



WINDSOR URBAN LTD.
ALL RIGHTS RESERVED.
UNAUTHORISED USE PROHIBITED

Rev	Description	Date	Des	Dn	Chk	Apd	Or Acp	Contractor	Designed	R. St-Denis / Conn	Sept 20
A	Issued to client for comments	04/09/20	RSD	RSD	-	-	-	-	Drawn	R. St-Denis / Conn	Sept 20
B	Issued to CCC for Final Approval	21/10/20	RSD	RSD	-	-	-	-	Checked	A. Kudinov / Conn	Oct 20
C	Issued to CCC for Final Approval	17/11/20	RSD	RSD	-	-	-	-	Approved	G. English / CCC	08/06/21
D	Column P19 Relocated 1.0m Behind the Kerb	09/06/21	RSD	RSD	-	-	-	-			

Scale
1:1000
Revision
D

STREETLIGHTING LAYOUT

Oakridges Sub-Division
Stage 1
Christchurch



611 Halswell Junction Rd, Hornby, Christchurch, NZ
Phone: (03) 349-7653 Fax: (03) 349-6529 Freephone: (0800) 845-845
Email: info@windsorurban.co.nz

Size	Drawing Number	Sheet
A3	400053	3/4